

AREA CALCULATION : -- IN sq.m

TOTAL PLOT AREA = 2711.85 SQM.
PERMISSIBLE F.A.R @3.50 = 9491.47 SQM.

(AREA IN SQM.)

BASEMENT FL. BUILT - UP AREA	= 20.04
GROUND FL. BUILT - UP AREA	= 755.17
1ST FL. BUILT - UP AREA	= 808.15
2ND FL. BUILT - UP ARE	= 808.15
3RD FL. BUILT - UP AREA	= 861.25
4TH FL. BUILT - UP AREA	= 861.25
5TH FL. BUILT - UP AREA	= 825.73
6TH FL. BUILT - UP AREA	= 839.29
7TH FL. BUILT - UP AREA	= 839.29
8TH FL. BUILT - UP AREA	= 839.29
9TH FL. BUILT - UP AREA	= 839.29
10TH FL. BUILT - UP AREA	= 839.29
TOTAL BUILT - UP AREA	= 9136.19

TOTAL PROPOSED F.A.R AREA ACHIEVED
= 9136.19 SQM. @ 3.36 F.A.R

DOOR WINDOW SCHEDULE			
TYPE	SIZE	CILL	LINTEL
RS	3.00X B.O.B	----	B.O.B
RS1	2.85X B.O.B	----	B.O.B
D	2.00 X 2.10	----	2.10
D1	1.80 X 2.10	----	2.10
D2	1.50 X 2.10	----	2.10
D3	1.20 X 2.10	----	2.10
D4	1.05X 2.10	----	2.10
D5	0.900 X 2.10	----	2.10
D6	0.750 X 2.10	----	2.10
W	2.40 X 1.20	0.90	2.10
W1	2.00 X 1.20	0.90	2.10

FIRE LEGEND	
FHC	FIRE HOSE CABINET
☼	UP RIGHT TYPE SPRINKLER
☼	PENDENT TYPE SPRINKLER
☼	SIDE WALL SPRINKLER
☼	9 Ltr. WATER GAS PRESSURE TYPE FIRE EXTINGUISHER
☼	4.5 kg CO ² TYPE FIRE EXTINGUISHER
☼	SLUICE VALVE
☼	NON-RETURN VALVE
☼	FLOW INDICATING SWITCH
☼	ELECTRICAL CALL POINT SWITCHES FOR THE ALARM SYSTEM.
☼	AREA COVERED WITH AUTOMATIC HEAT SMOKE DETECTOR AS PER I.S.S.
FD	DOUBLE LEAF DOUBLE SWING SELF CLOSING FIRE RESISTING DOOR
☼	HOUSE RULES AS PER I.S.S.T.A.C. RECOMMENDATIONS DULY CONNECTED WITH THE WET RISER SYSTEM.
☼	LANDING VALVES AS PER I.S.S.T.A.C. RECOMMENDATIONS DULY CONNECTED WITH THE WET RISER SYSTEM.
☼	LOUD SPEAKER OUTLETS FOR THE PUBLIC ADDRESS SYSTEM.
M	MICRO PHONE POSITION FOR THE PUBLIC ADDRESS SYSTEM.
☼	FLOOR INDICATOR PANELS FOR THE AUTOMATIC FIRE ALARM SYSTEM AS PER I.S.S.
☼	WATER CO ² TYPE PORTABLE EXTINGUISHER OF 9 LITRE CAPACITY.
☼	EAM CONNECTION TO THE WET RISING SYSTEM.
EXIT	EXIST DIRECTIONAL SIGN.
☼	PORTABLE CHEMICAL B.C.F. EXTINGUISHER OF 3.5 KG CAPACITY.


PROJECT:

PROPOSED JALALPUR MEGA MART
AT PHULWARI SHARIF, PATNA , BIHAR
FOR M/S : JALALPUR INFRASTRUCTURE PVT. LTD.
THROUGHT ITS DIRECTOR
UTTAM KUMAR
S/O LATE ISHWARI SINGH
PLOT NO. - 487,
THANA NO. - 40,
TAUZI - 5127,
KHATA NO.- 11,
DIST. - PATNA.

SHEET TITTLE:

FLOOR PLAN

SCALE = 1:100
OR
Mentioned

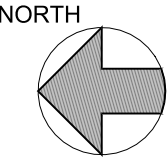

SHEET NO. - 05

SIGNATURE OF OWNER/ FIRM / COMPANY

ARCHITECT:


DES ARC
ARCHITECTS, INTERIORS, PLANNING

UGSR - 1A, ANSAL PLAZA - SECTOR - I, VAISHALI, GZB
PH: 0120 - 4140410 M : 0-9818711273
EMAIL- desarc14@gmail.com


Nishant Shekhar
NISHANT SHEKHAR
CA/2006/39203

SIGNATURE OF ARCHITECT

SIGNATURE OF STRUCTURAL ENGINEER

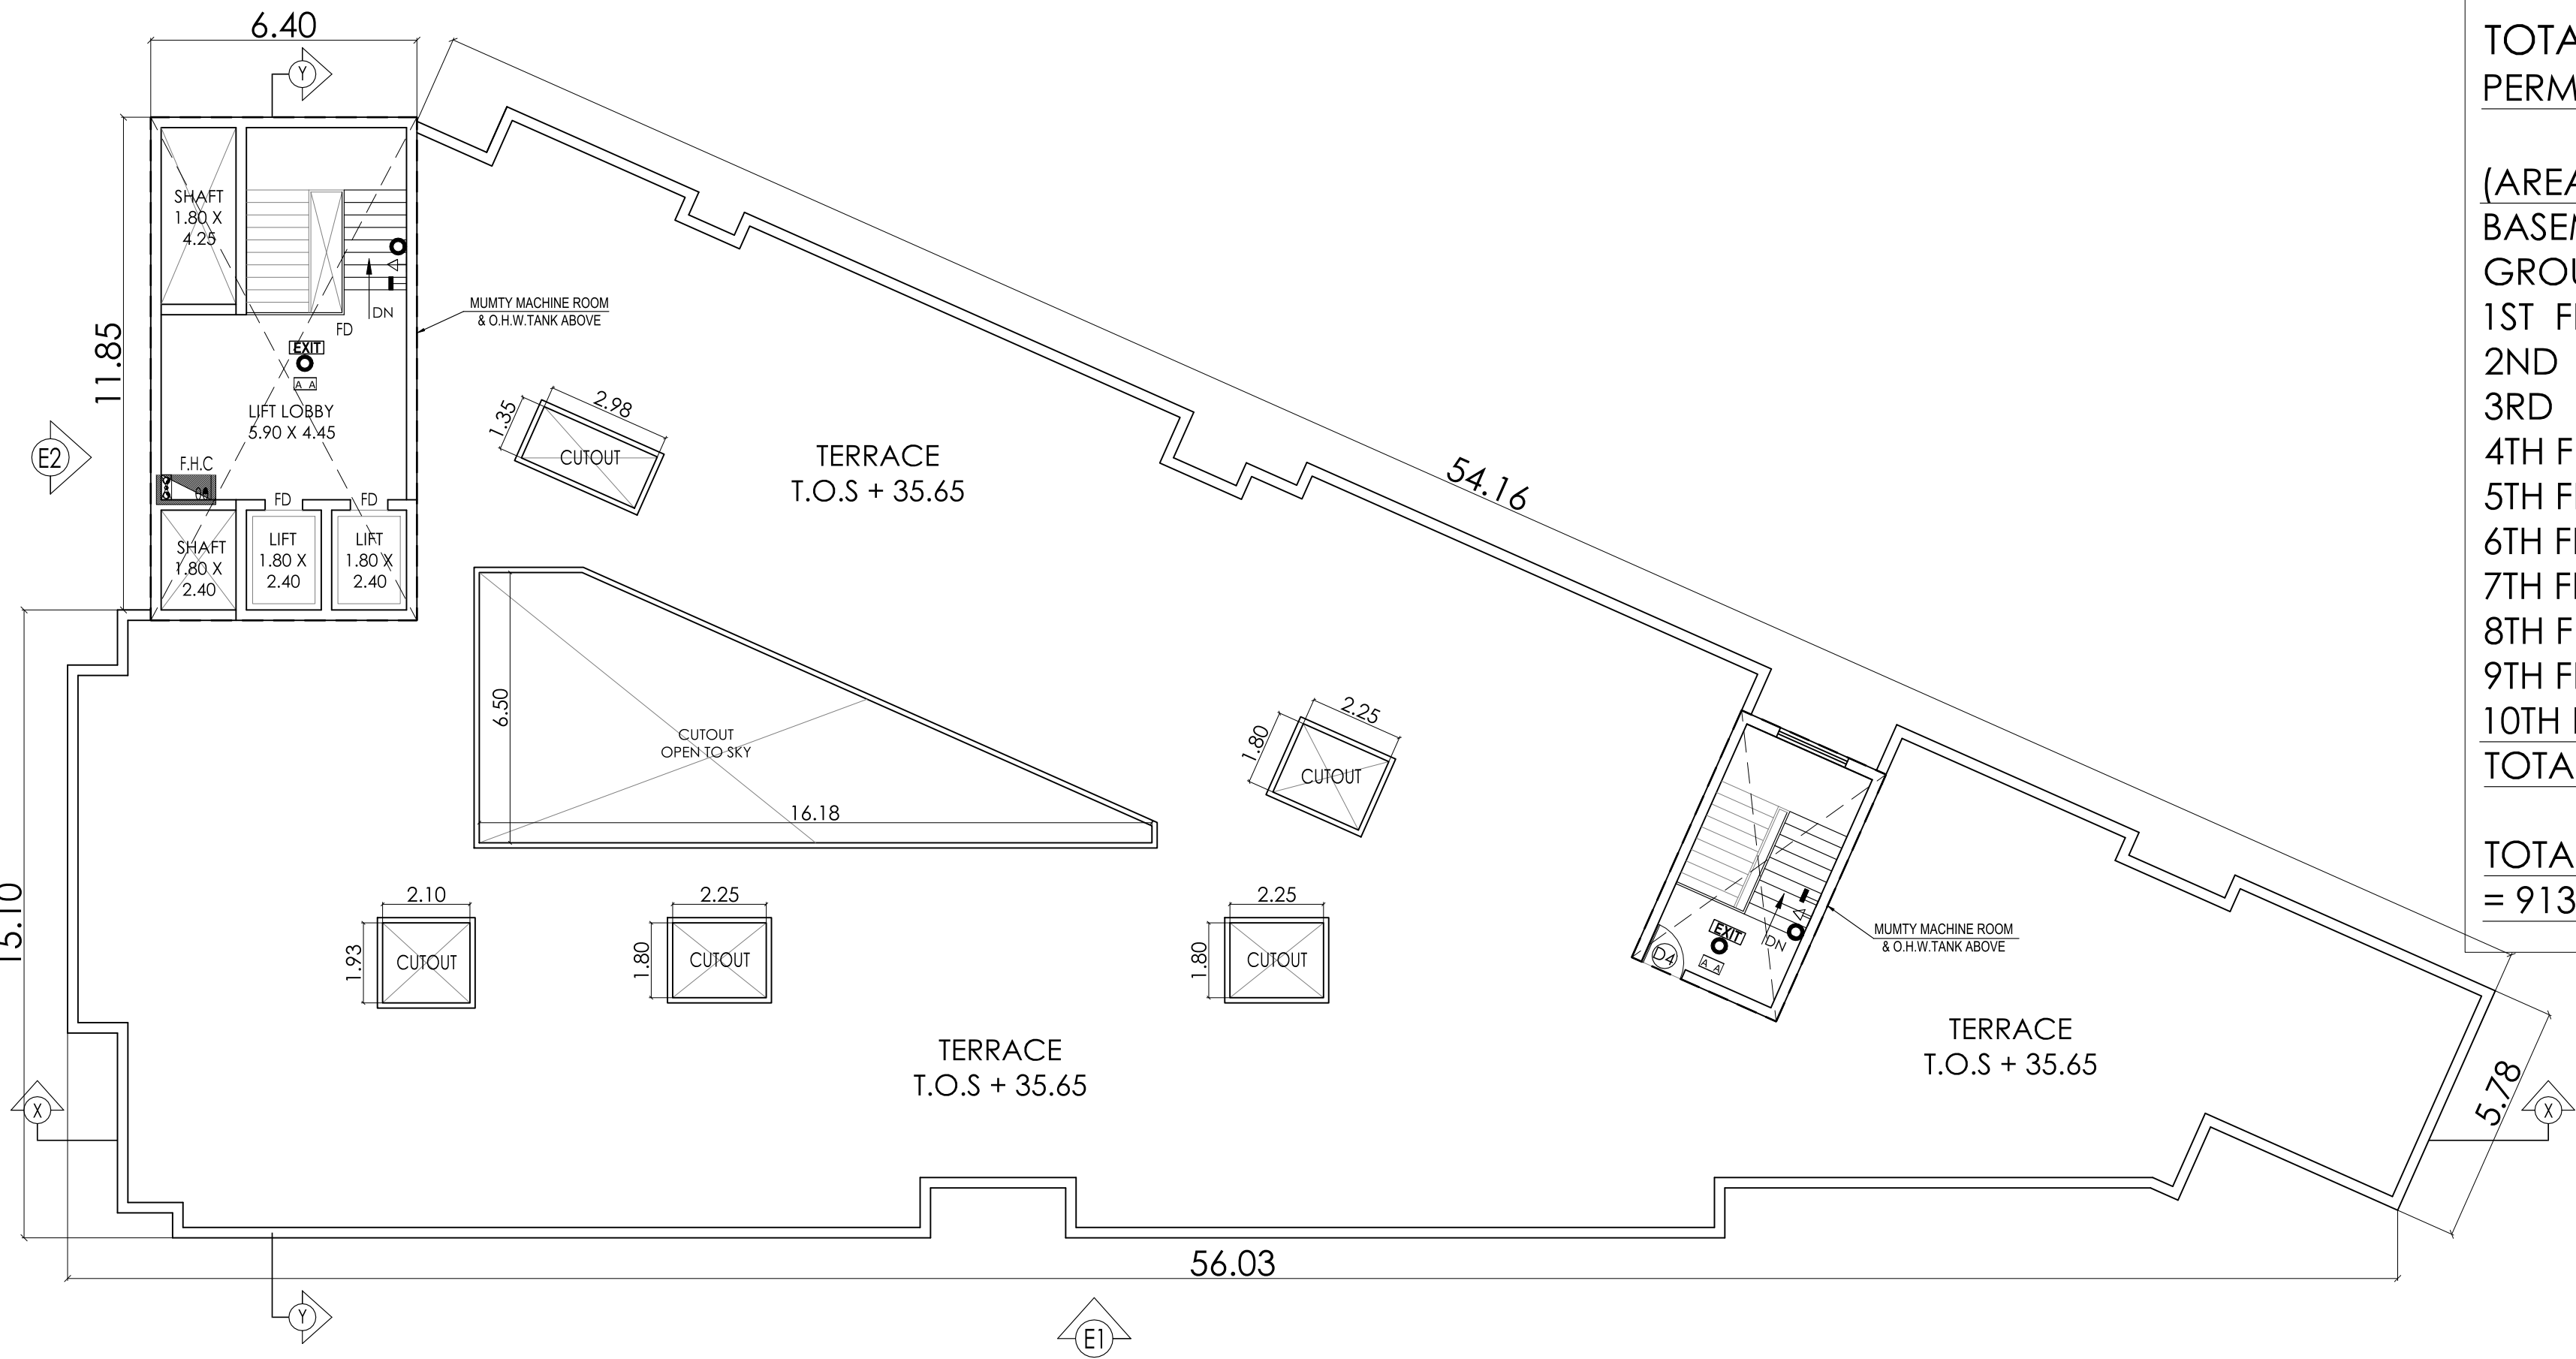

6TH TO 10TH FLOOR PLAN

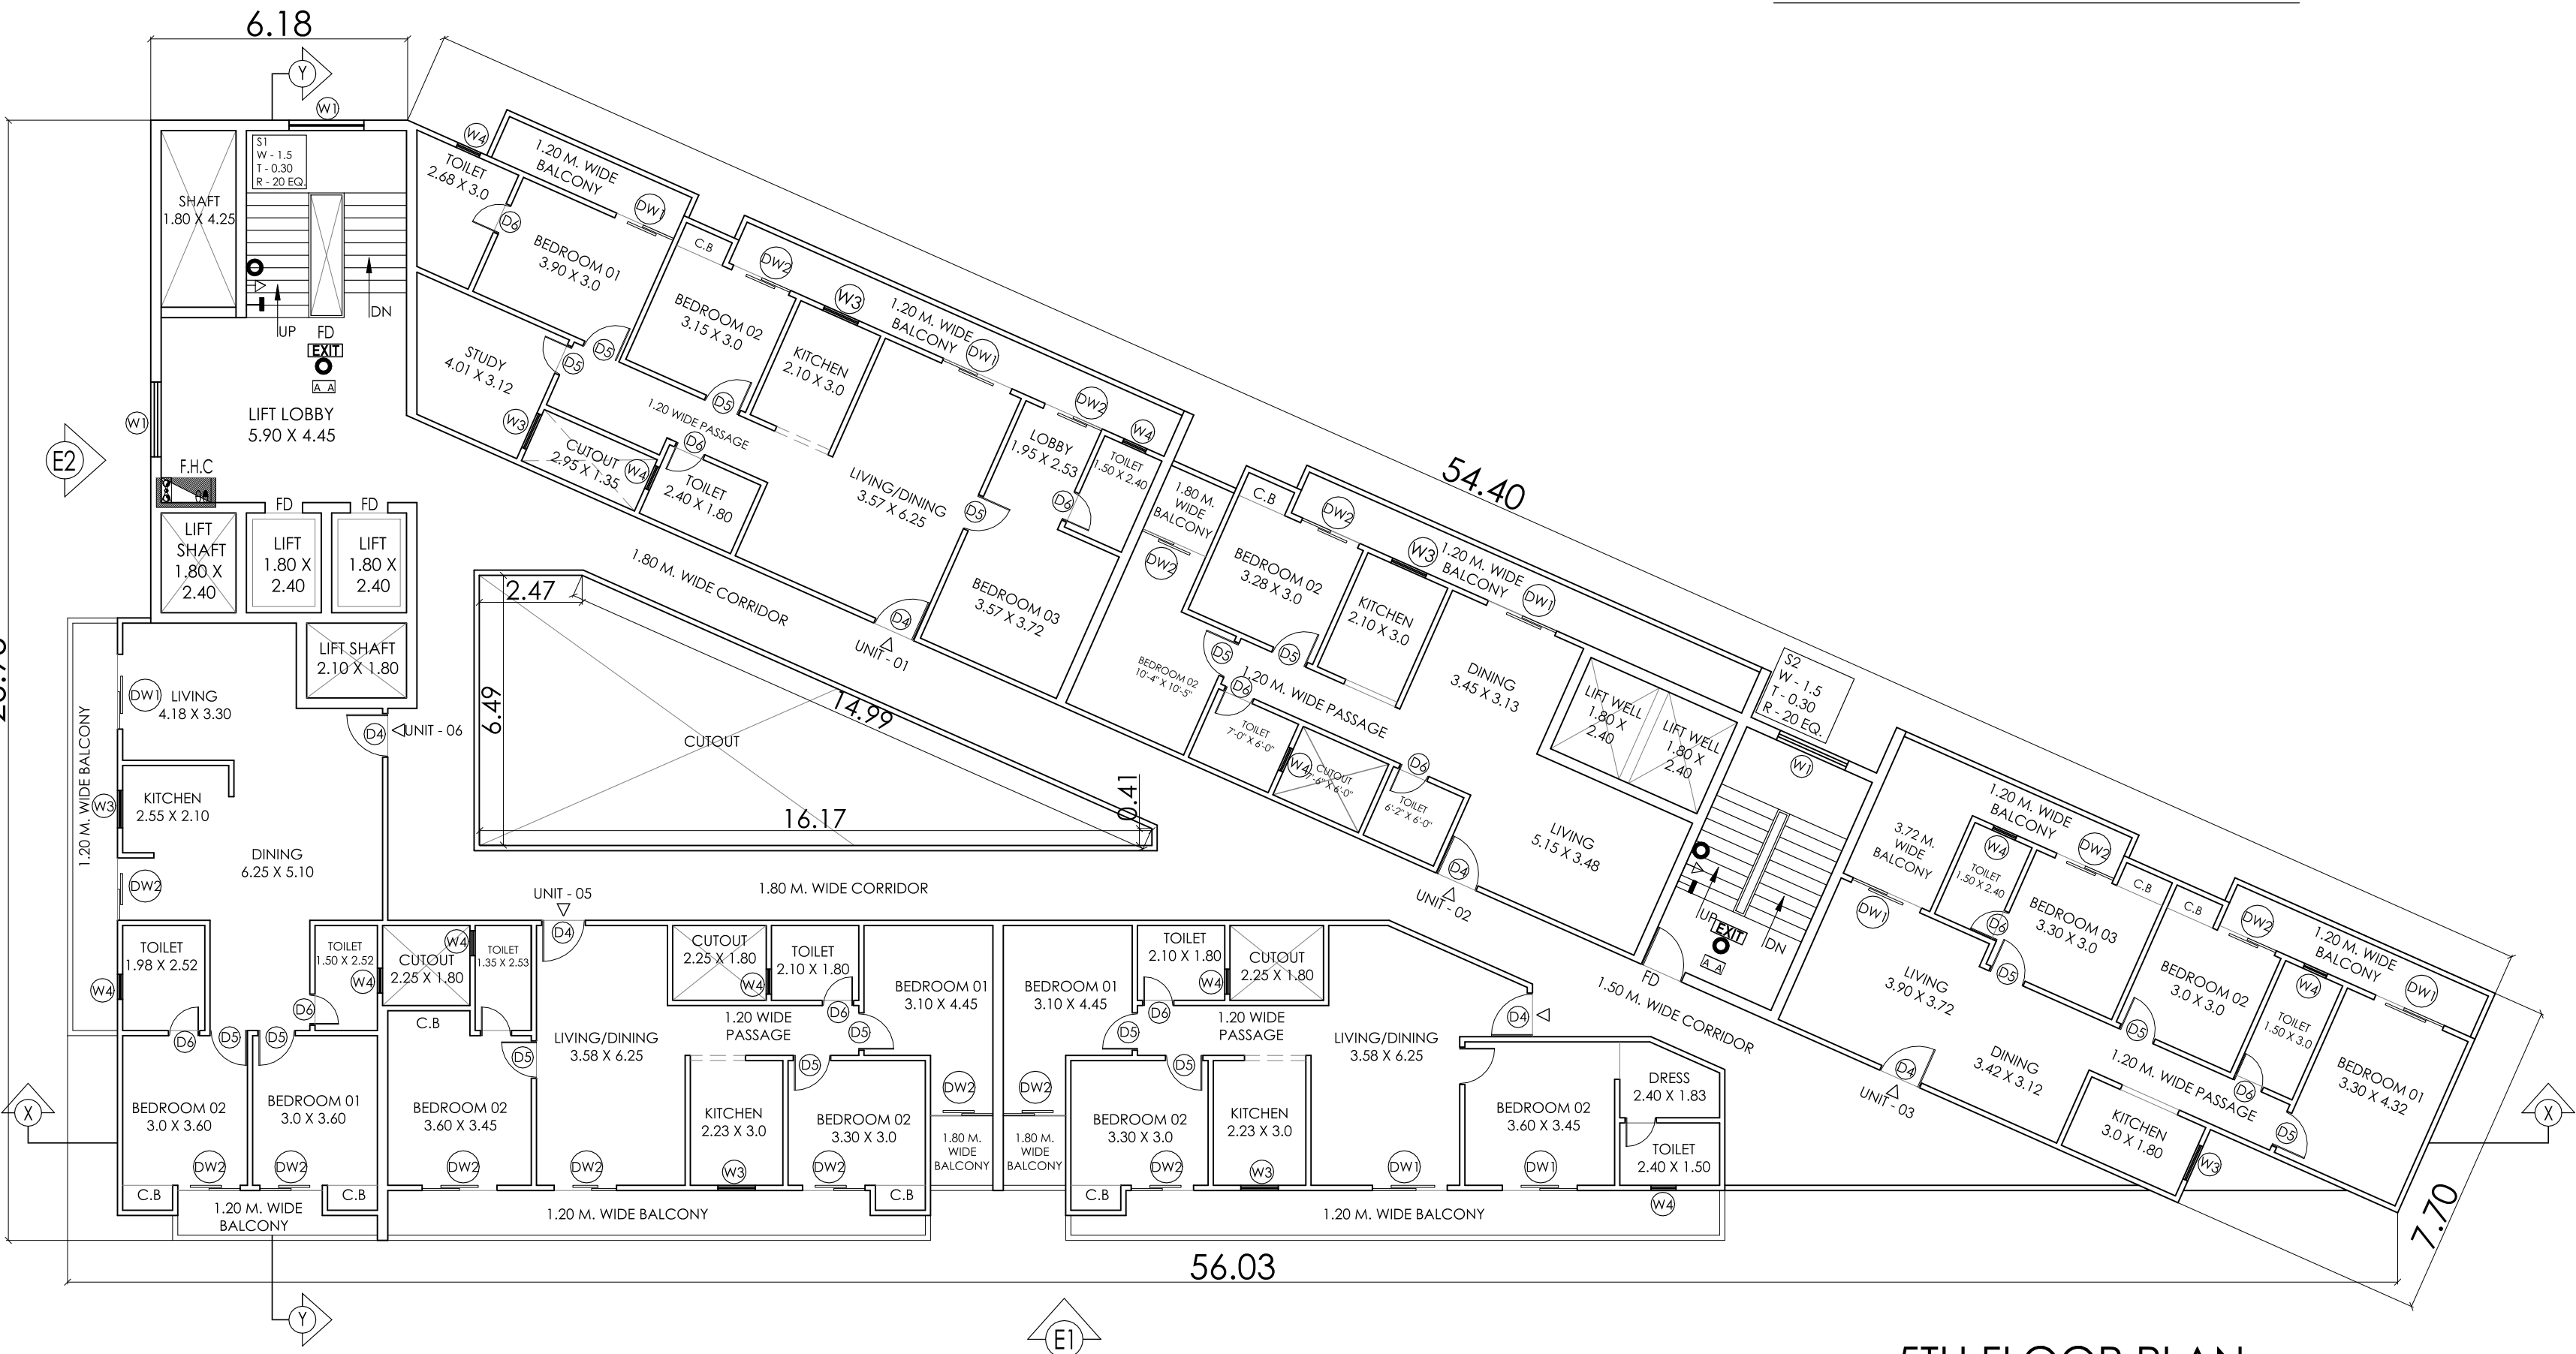

5TH FLOOR PLAN